


THERAPEUTIC SPLASH PAD FOR ELLISVILLE STATE SCHOOL CONTRACT "B"

ELLISVILLE, MISSISSIPPI

CNC PROJECT NO: ESS-102-18-B

BID ISSUE

DECEMBER 12, 2019

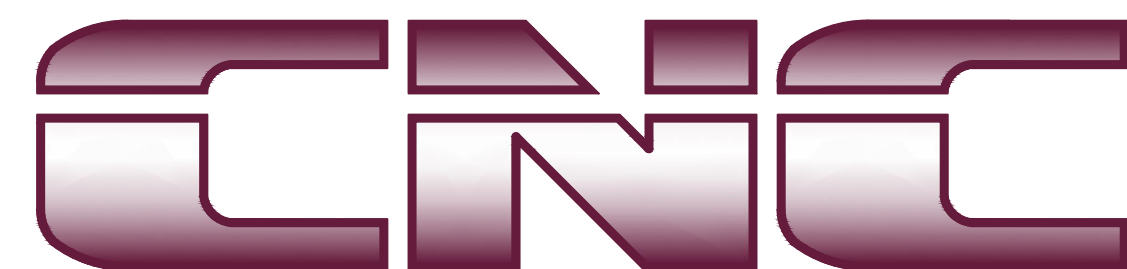


CHAS. N. CLARK ASSOC., LTD.
Consulting Engineers


714 Hillcrest Dr. • Laurel, MS 39440
601-649-5900 • (Fax) 601-649-5963

DRAWING INDEX


- 0.0 TITLE SHEET
- 1.0 EXISTING SITE PLAN
- 2.0 PROPOSED SITE PLAN

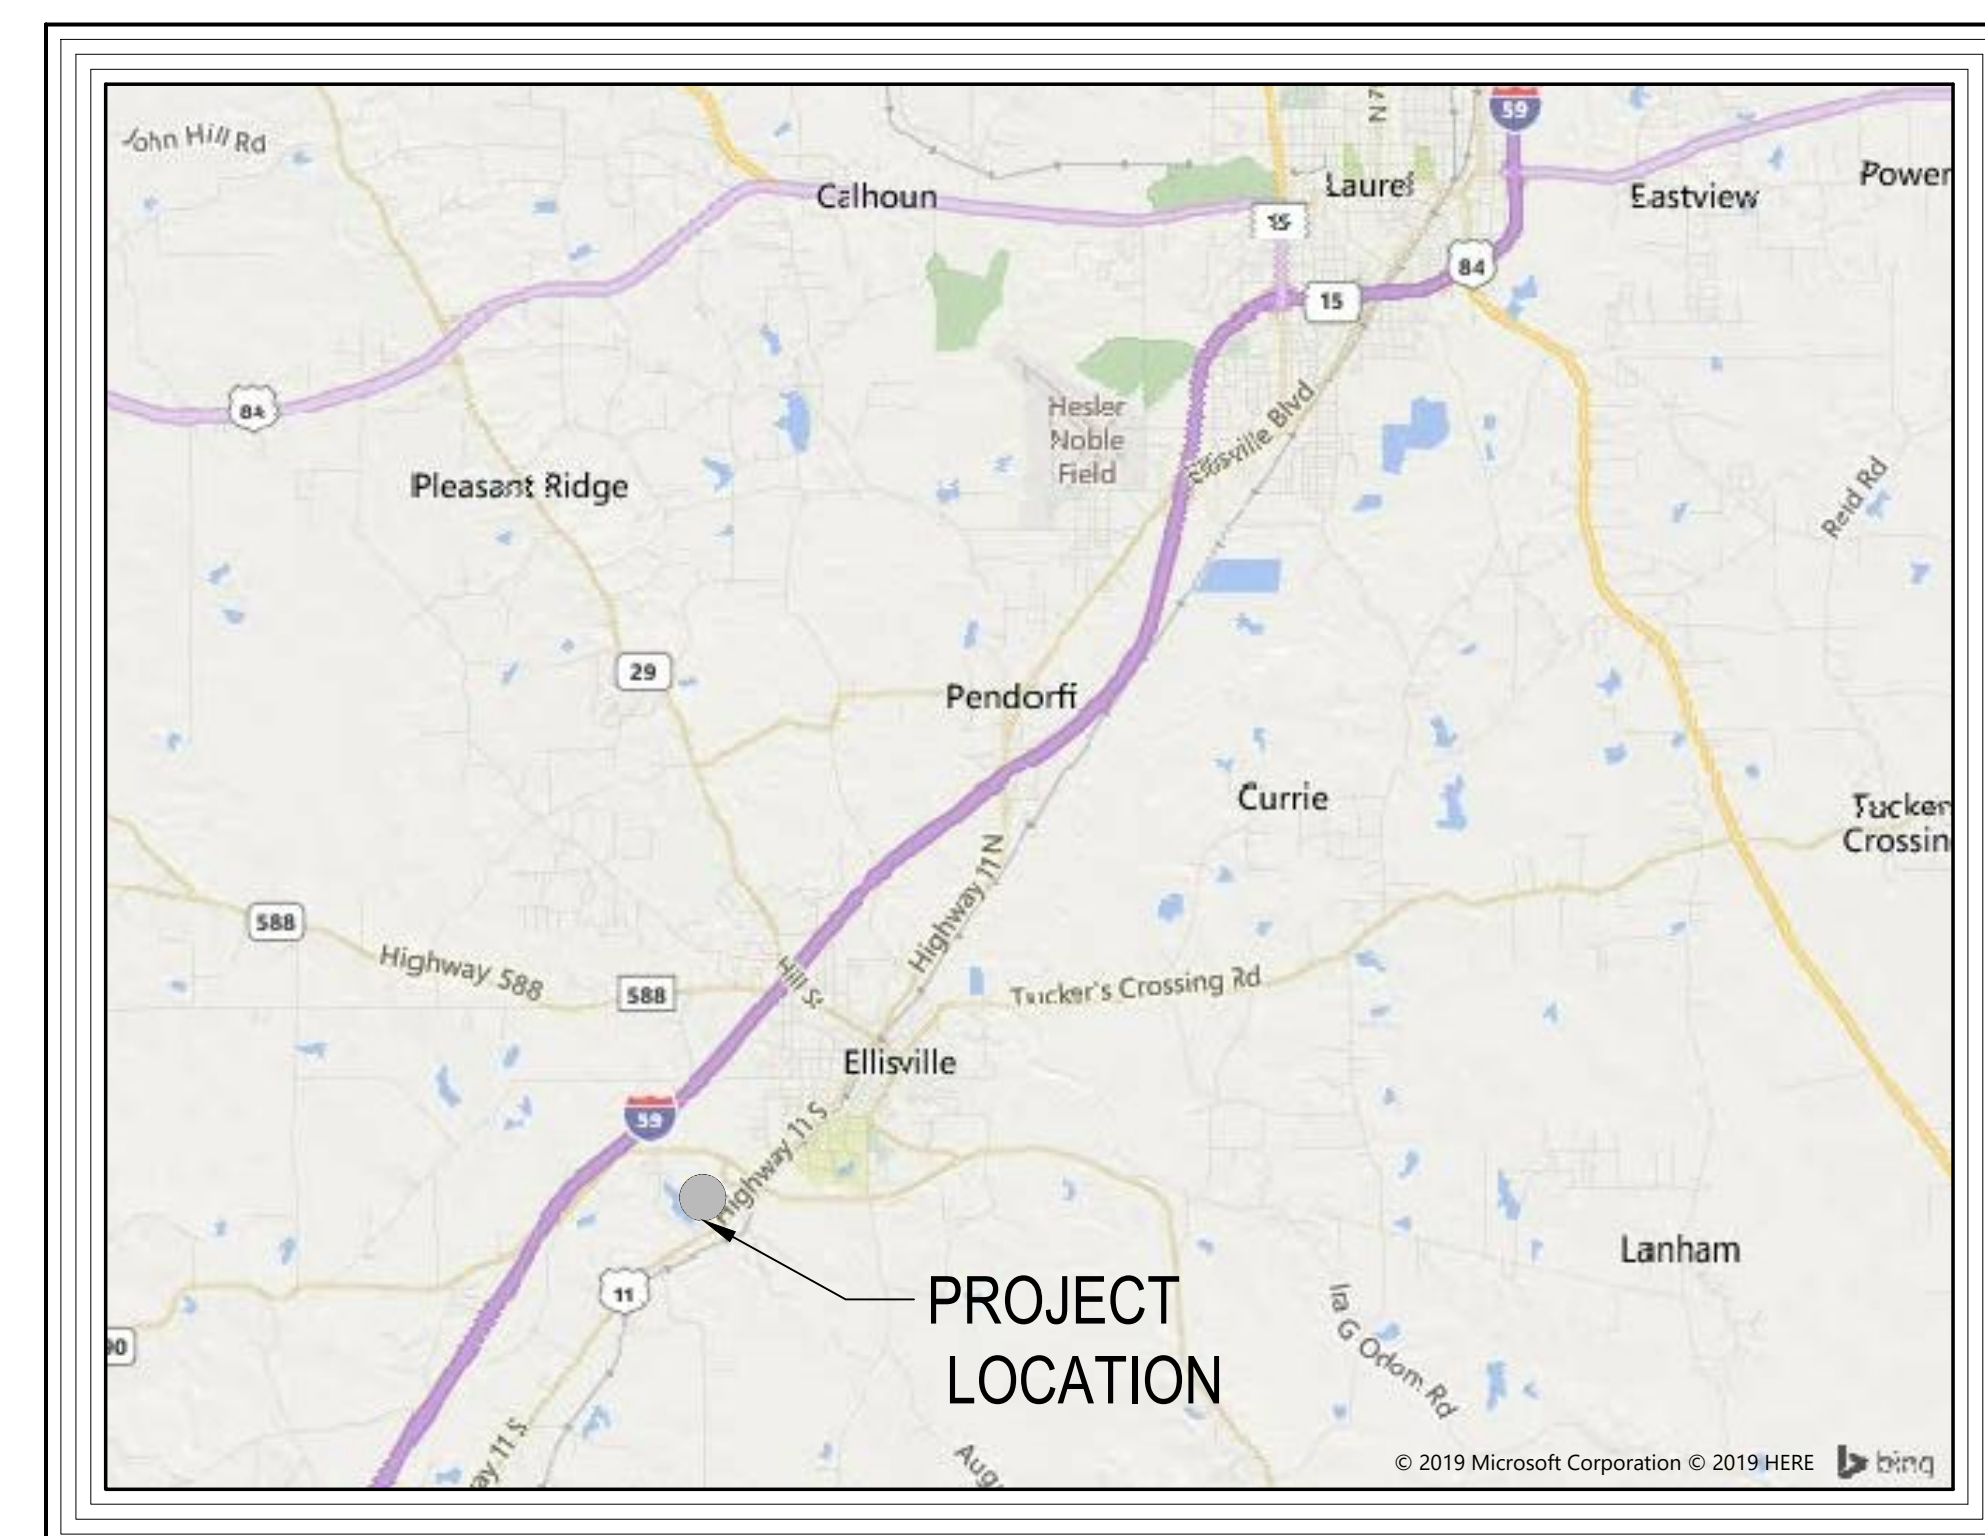

VICINITY MAP

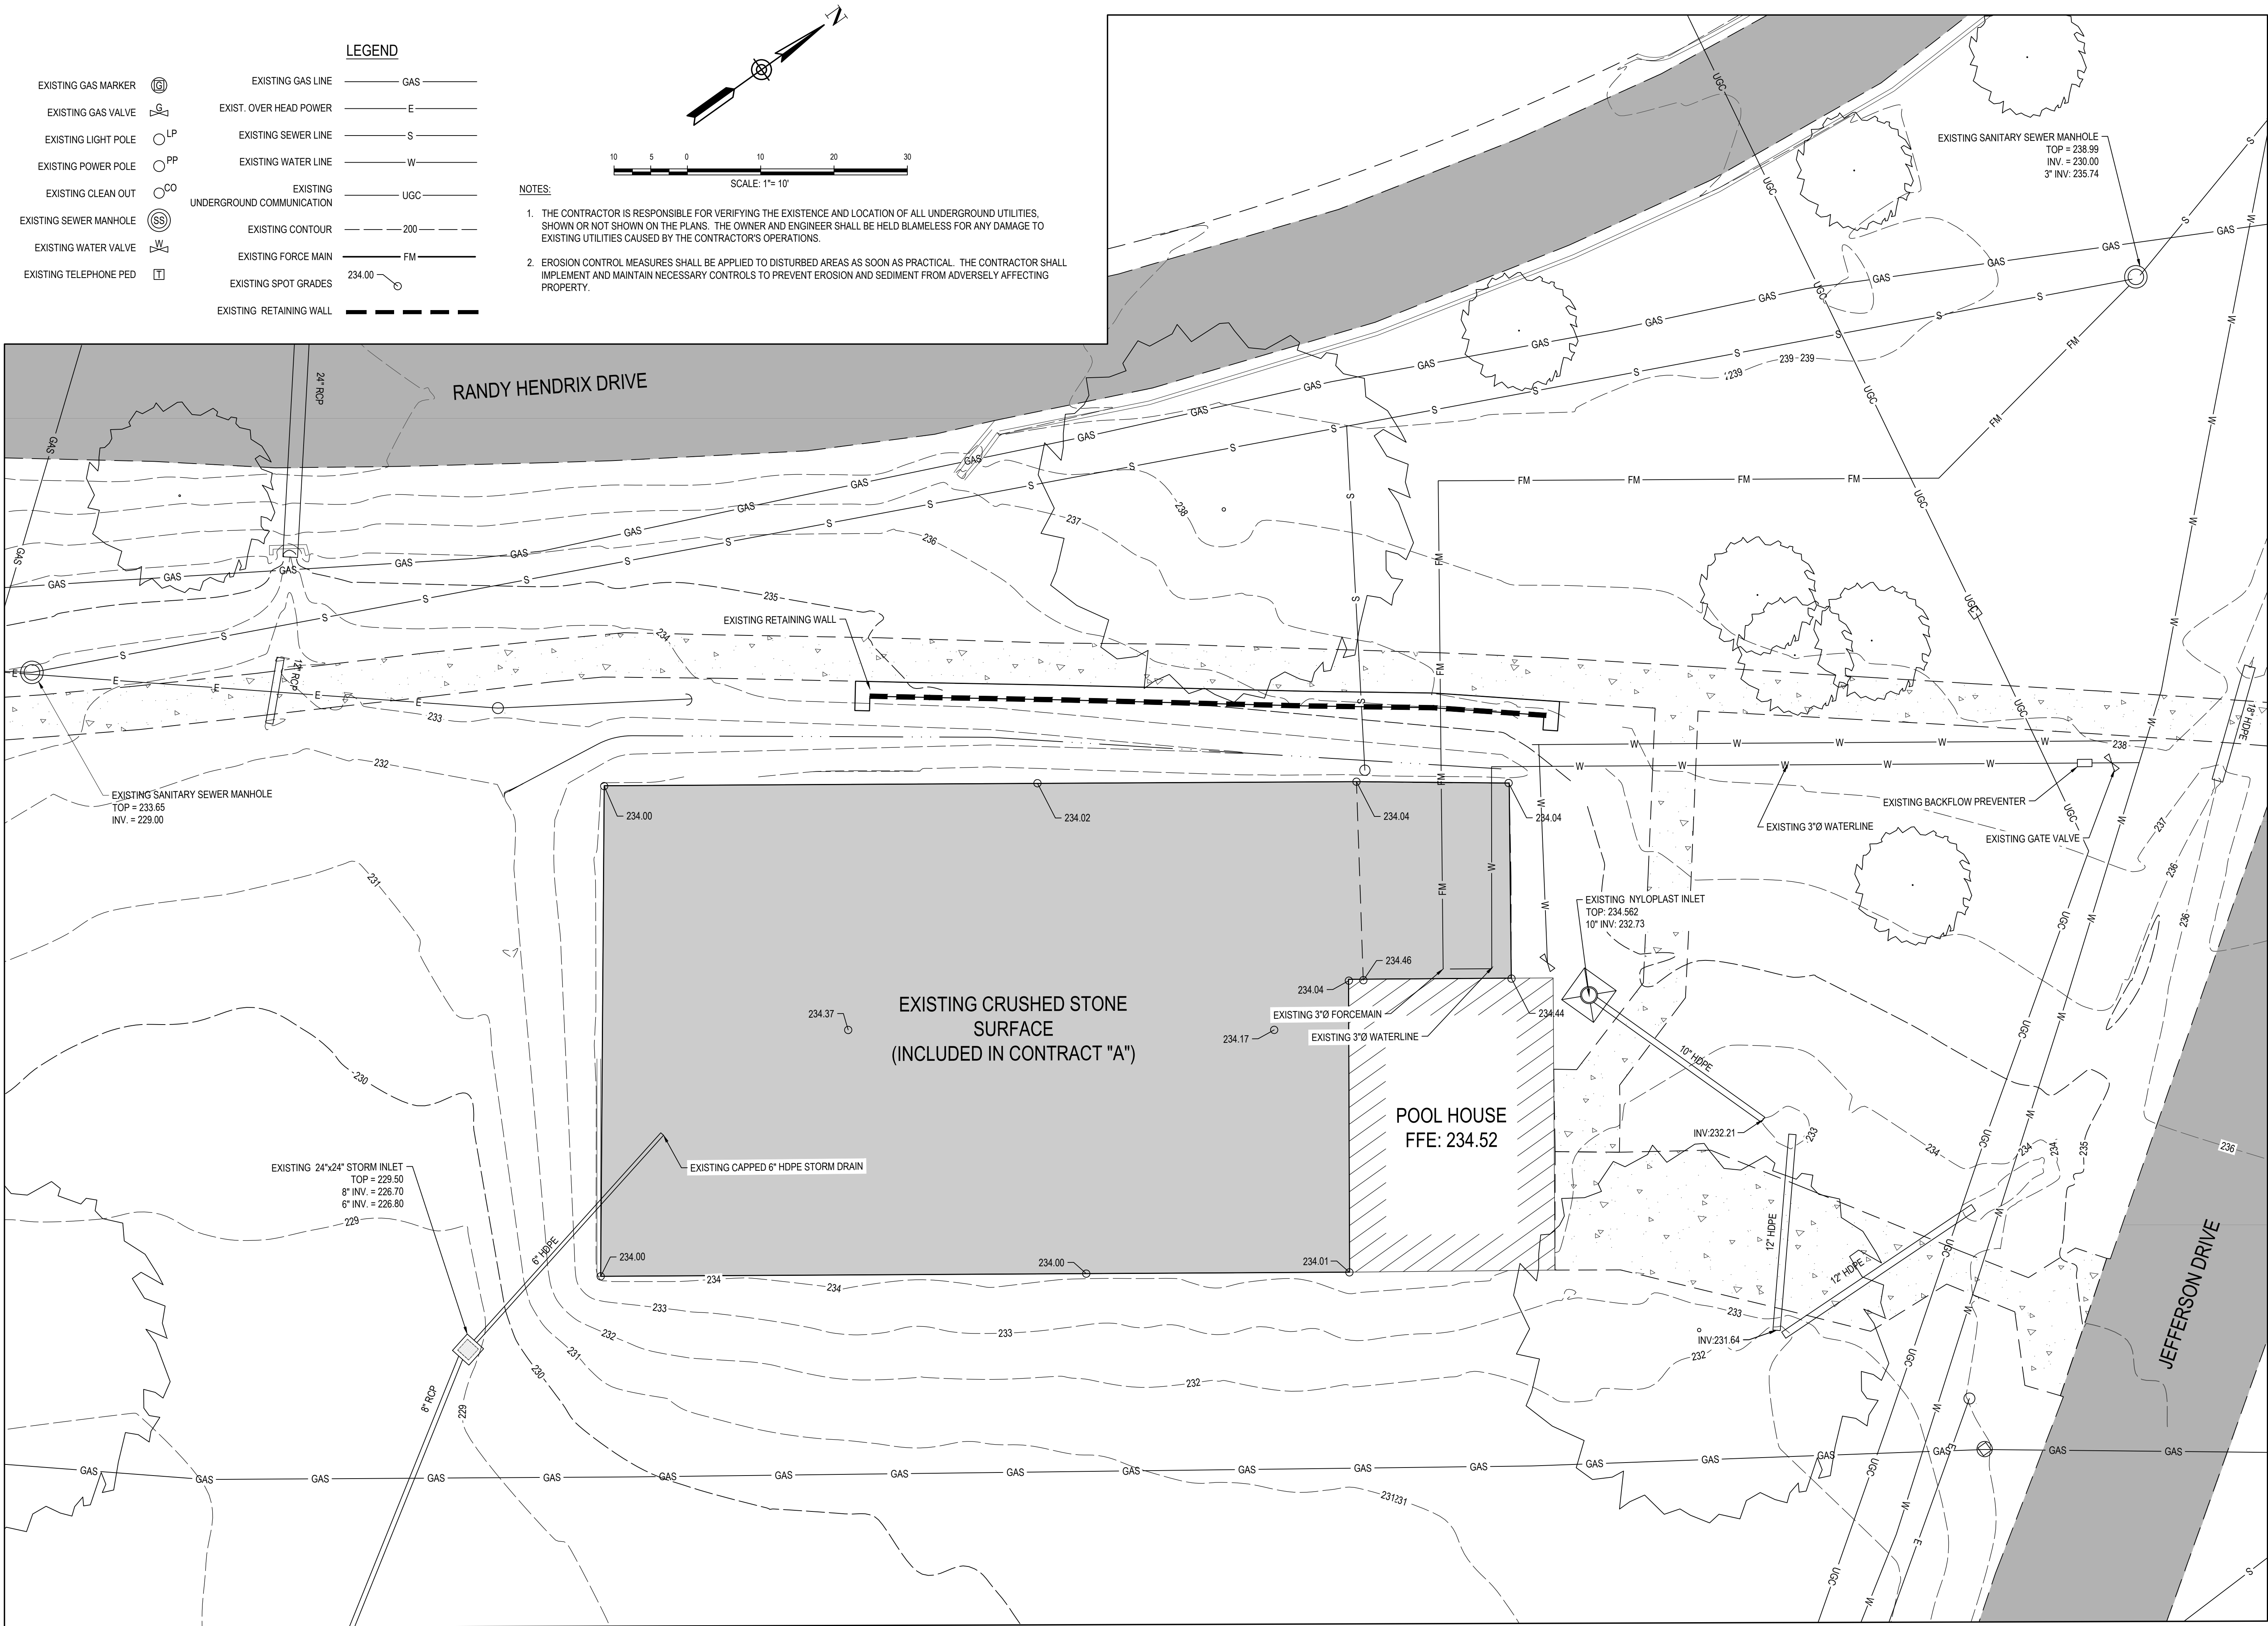

REVISIONS			
NO.	TYPE	DESCRIPTION	DATE
1	---	BID ISSUE	12/12/2019

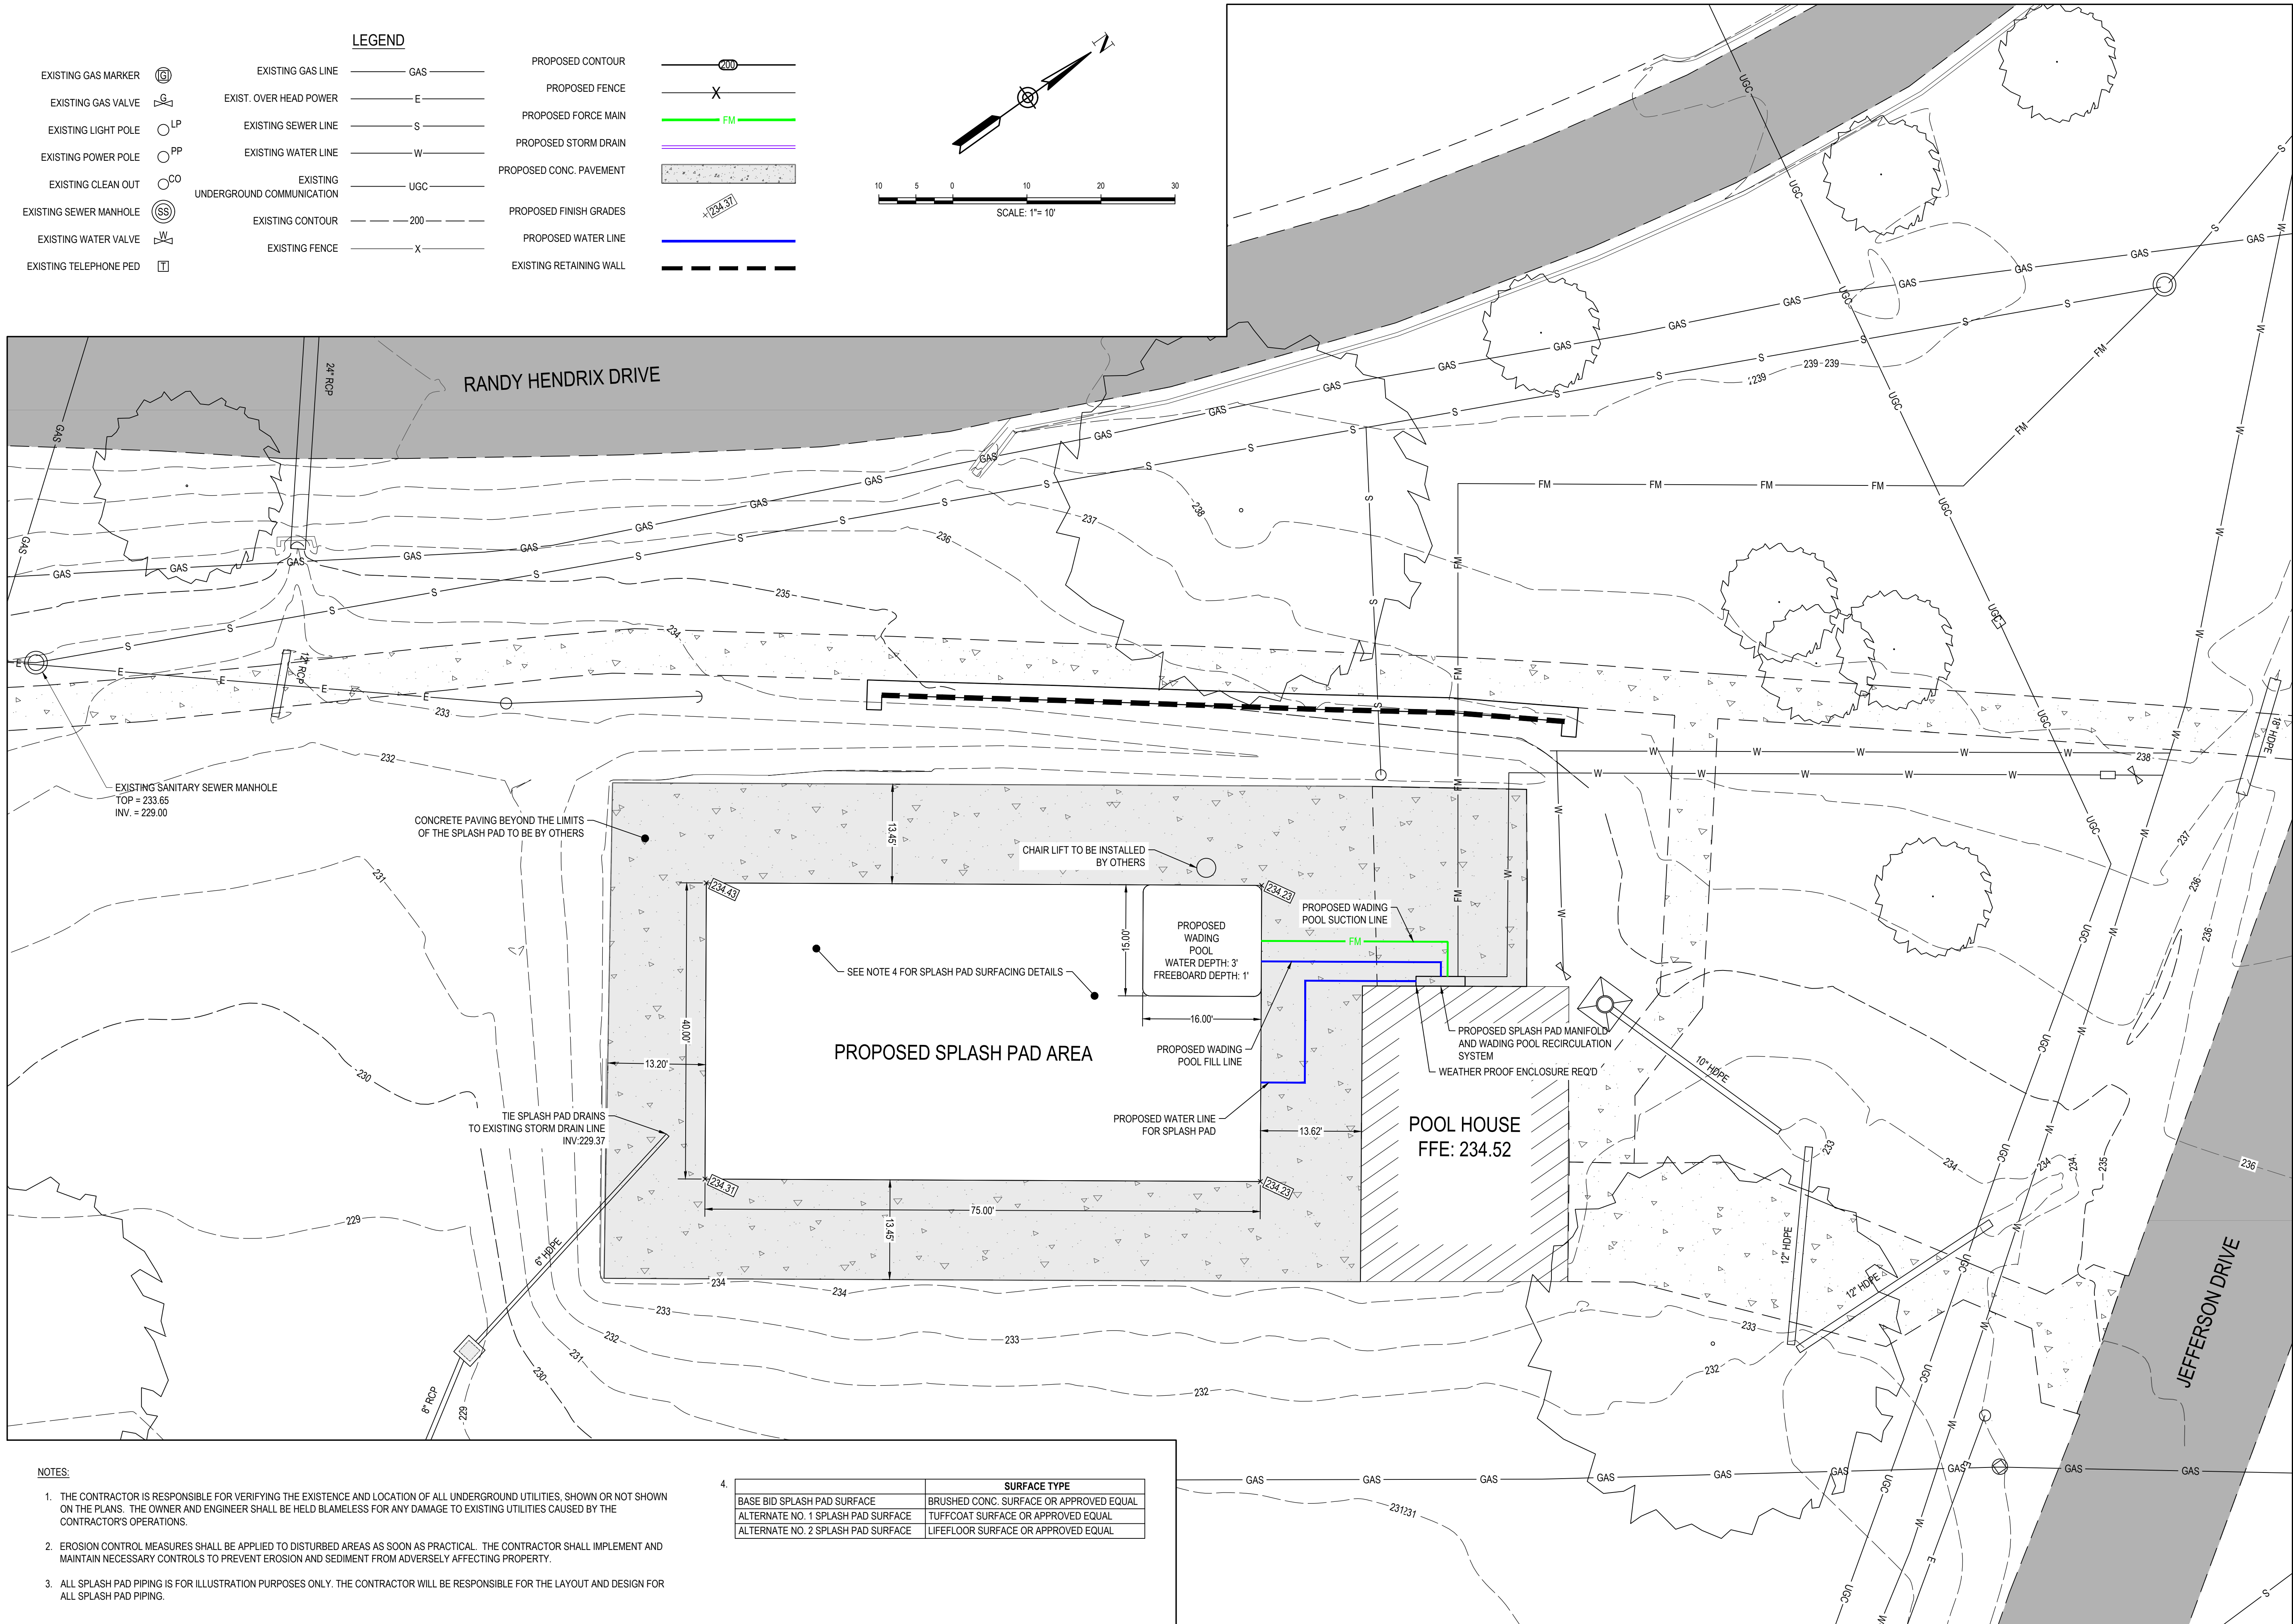

REVISIONS			
NO.	TYPE	DESCRIPTION	DATE
1	---	BID ISSUE	12/12/2019

**PROPOSED
SITE PLAN**

Project No: ESS-102-18-B
Date: 12-12-19
Designed: LDW
Drawn: MSH
Checked: JWP/LDW

Sheet No.
2.0